
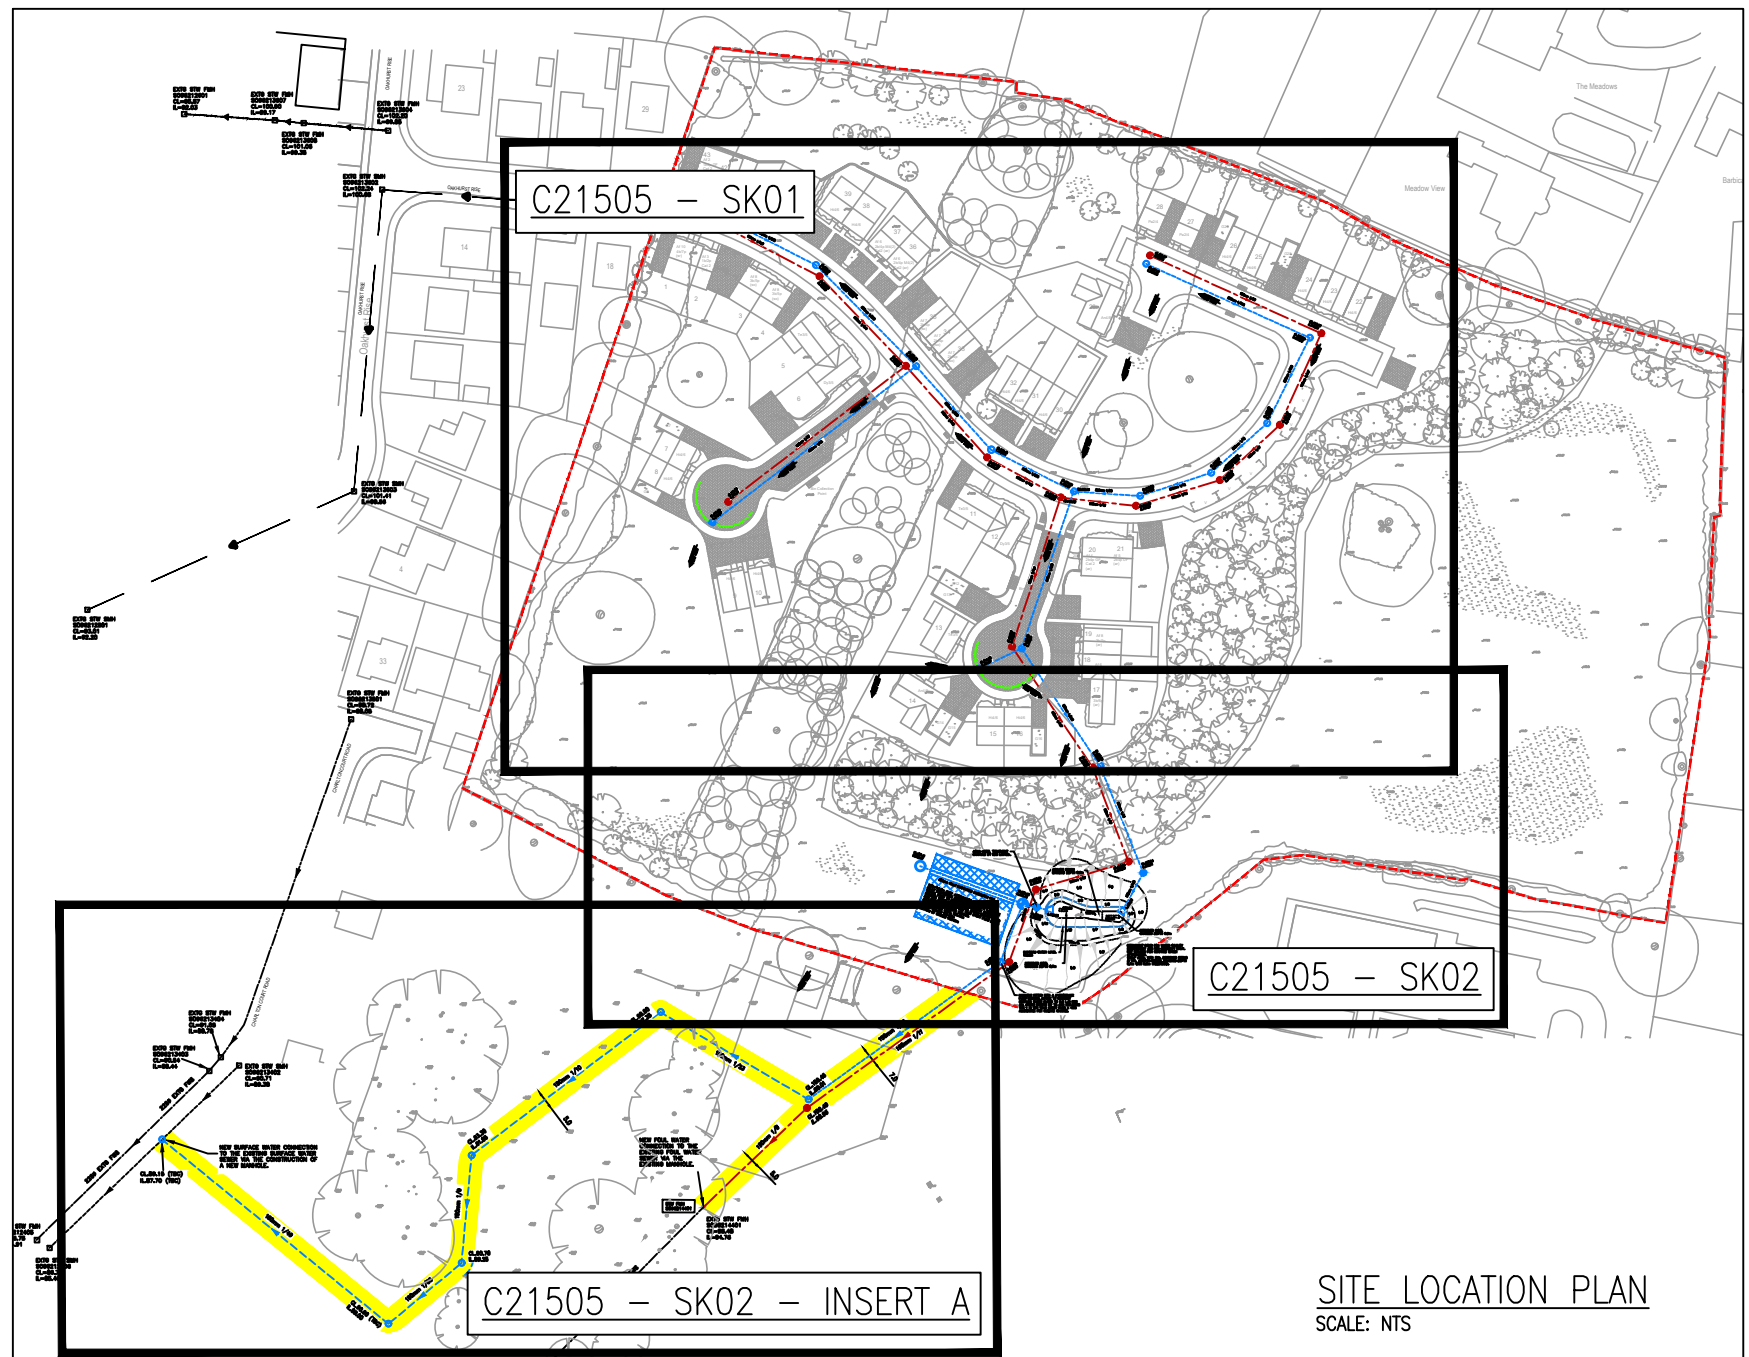
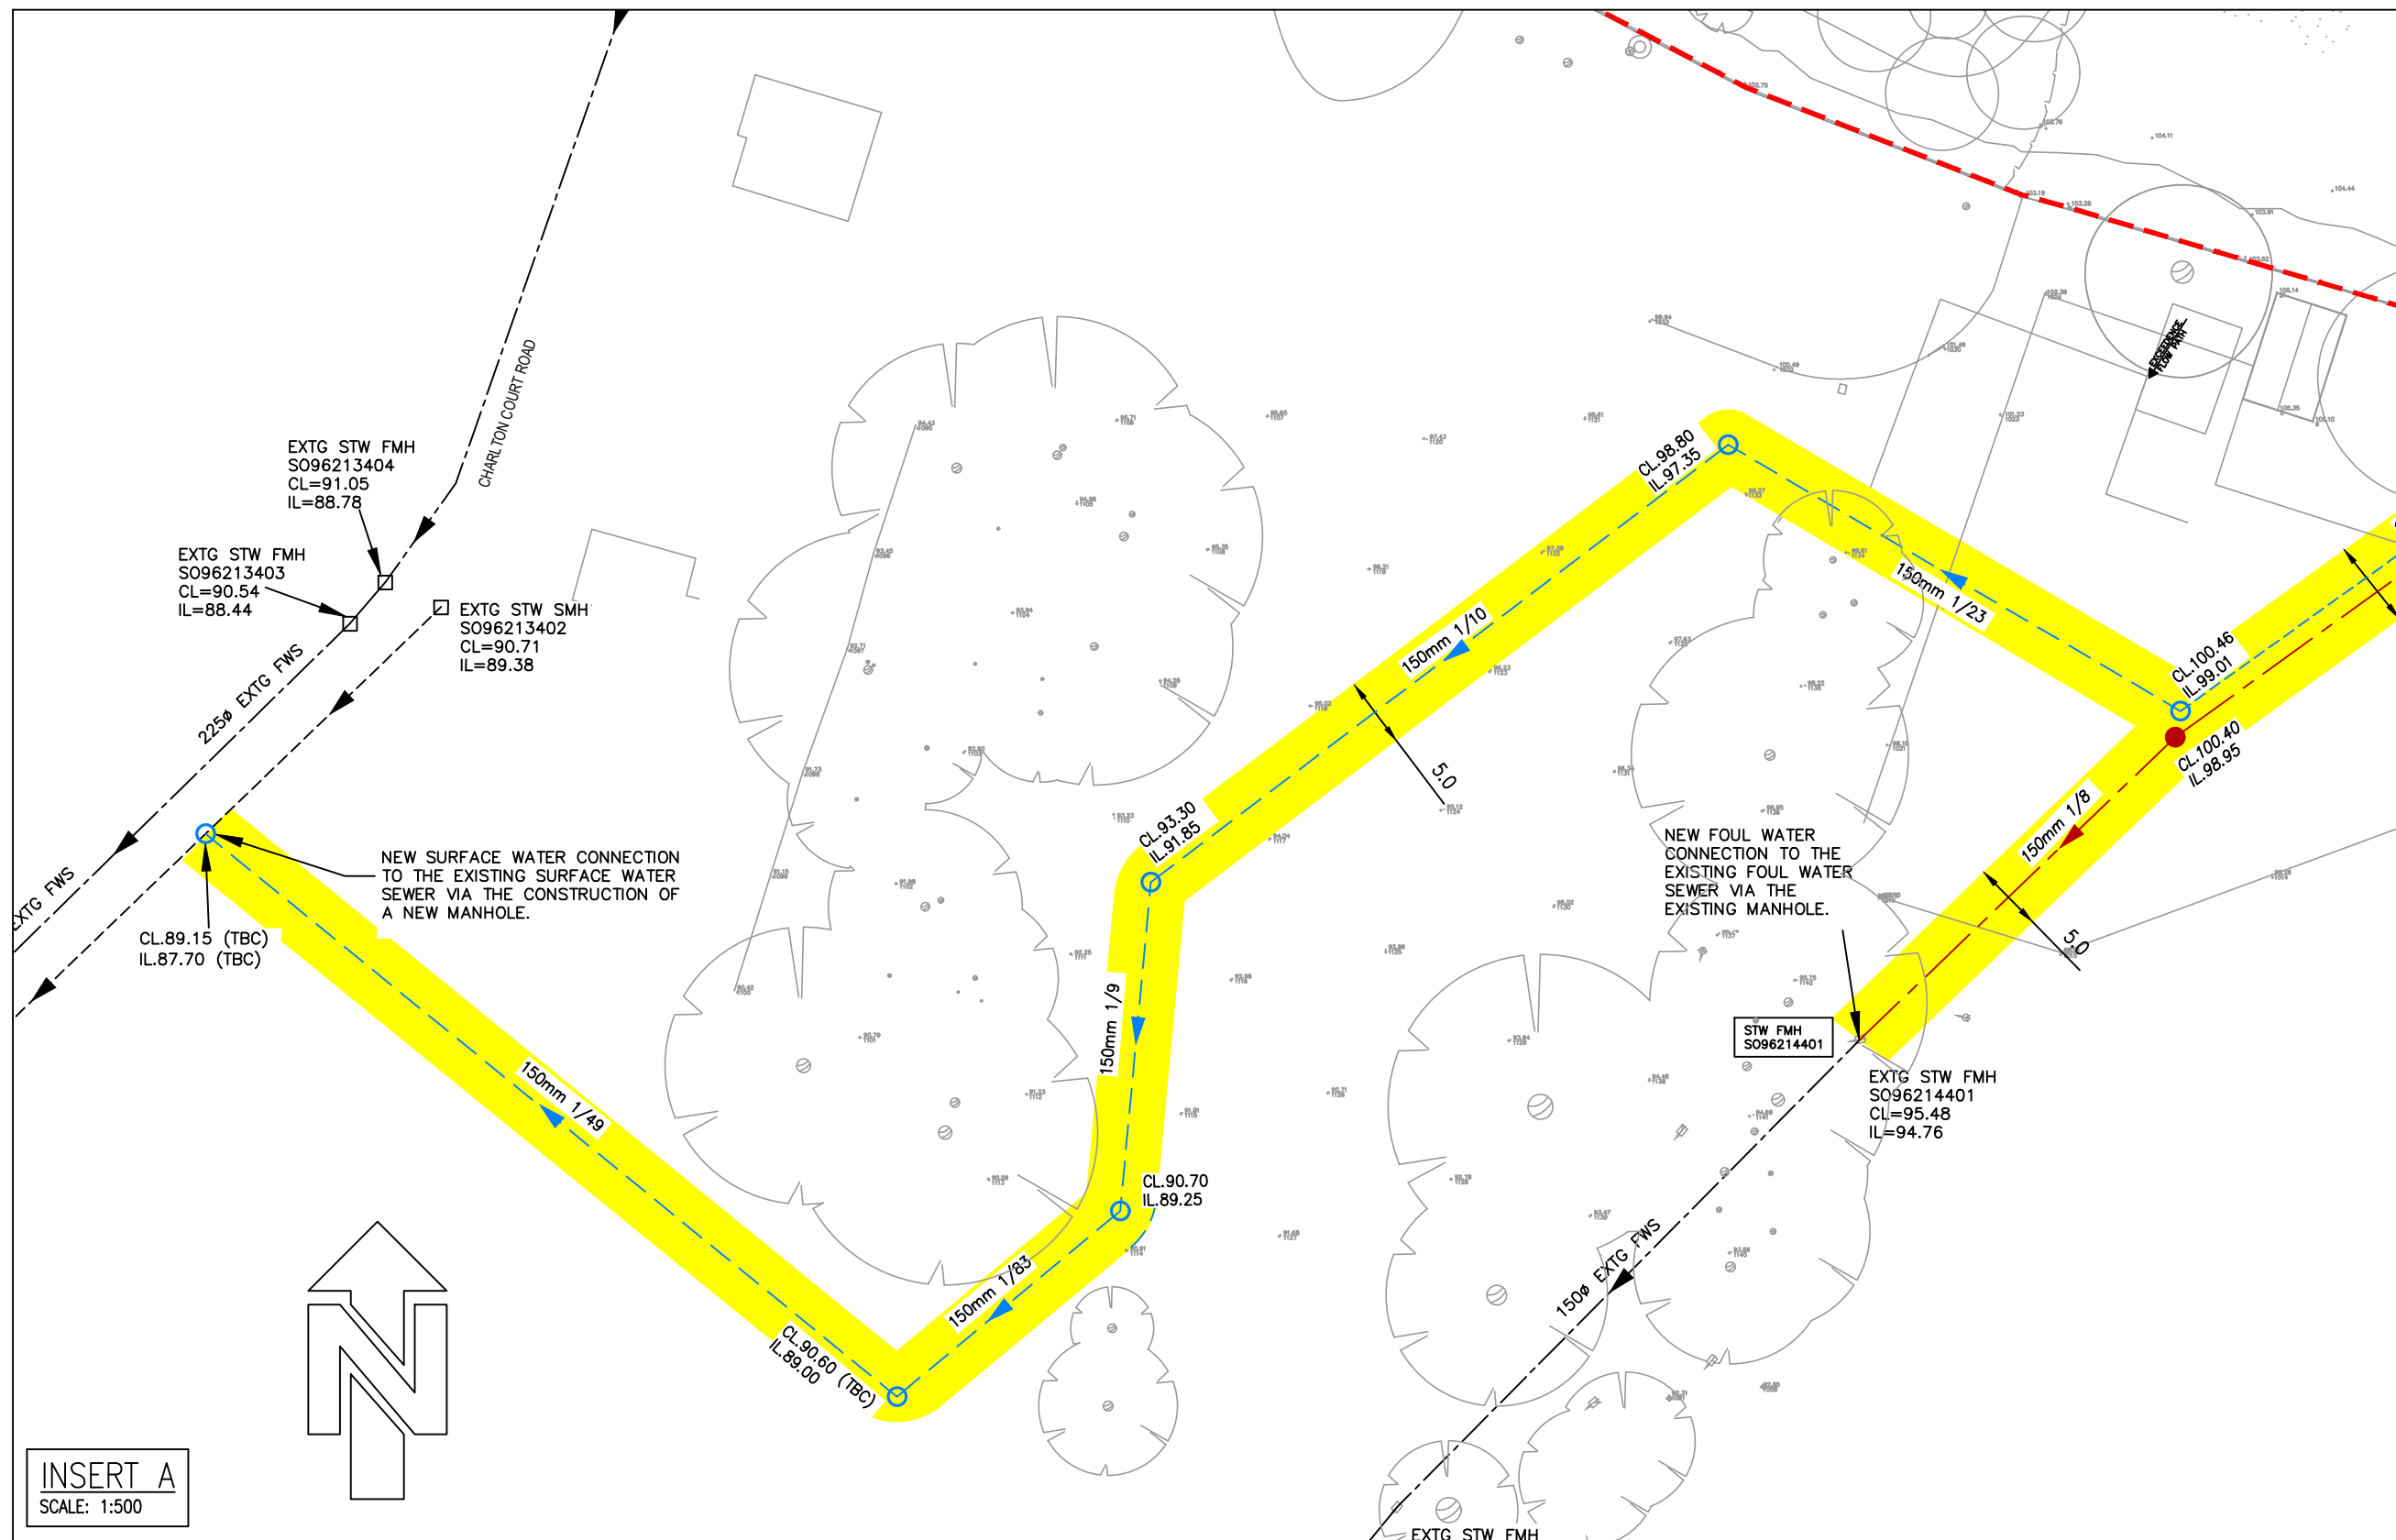


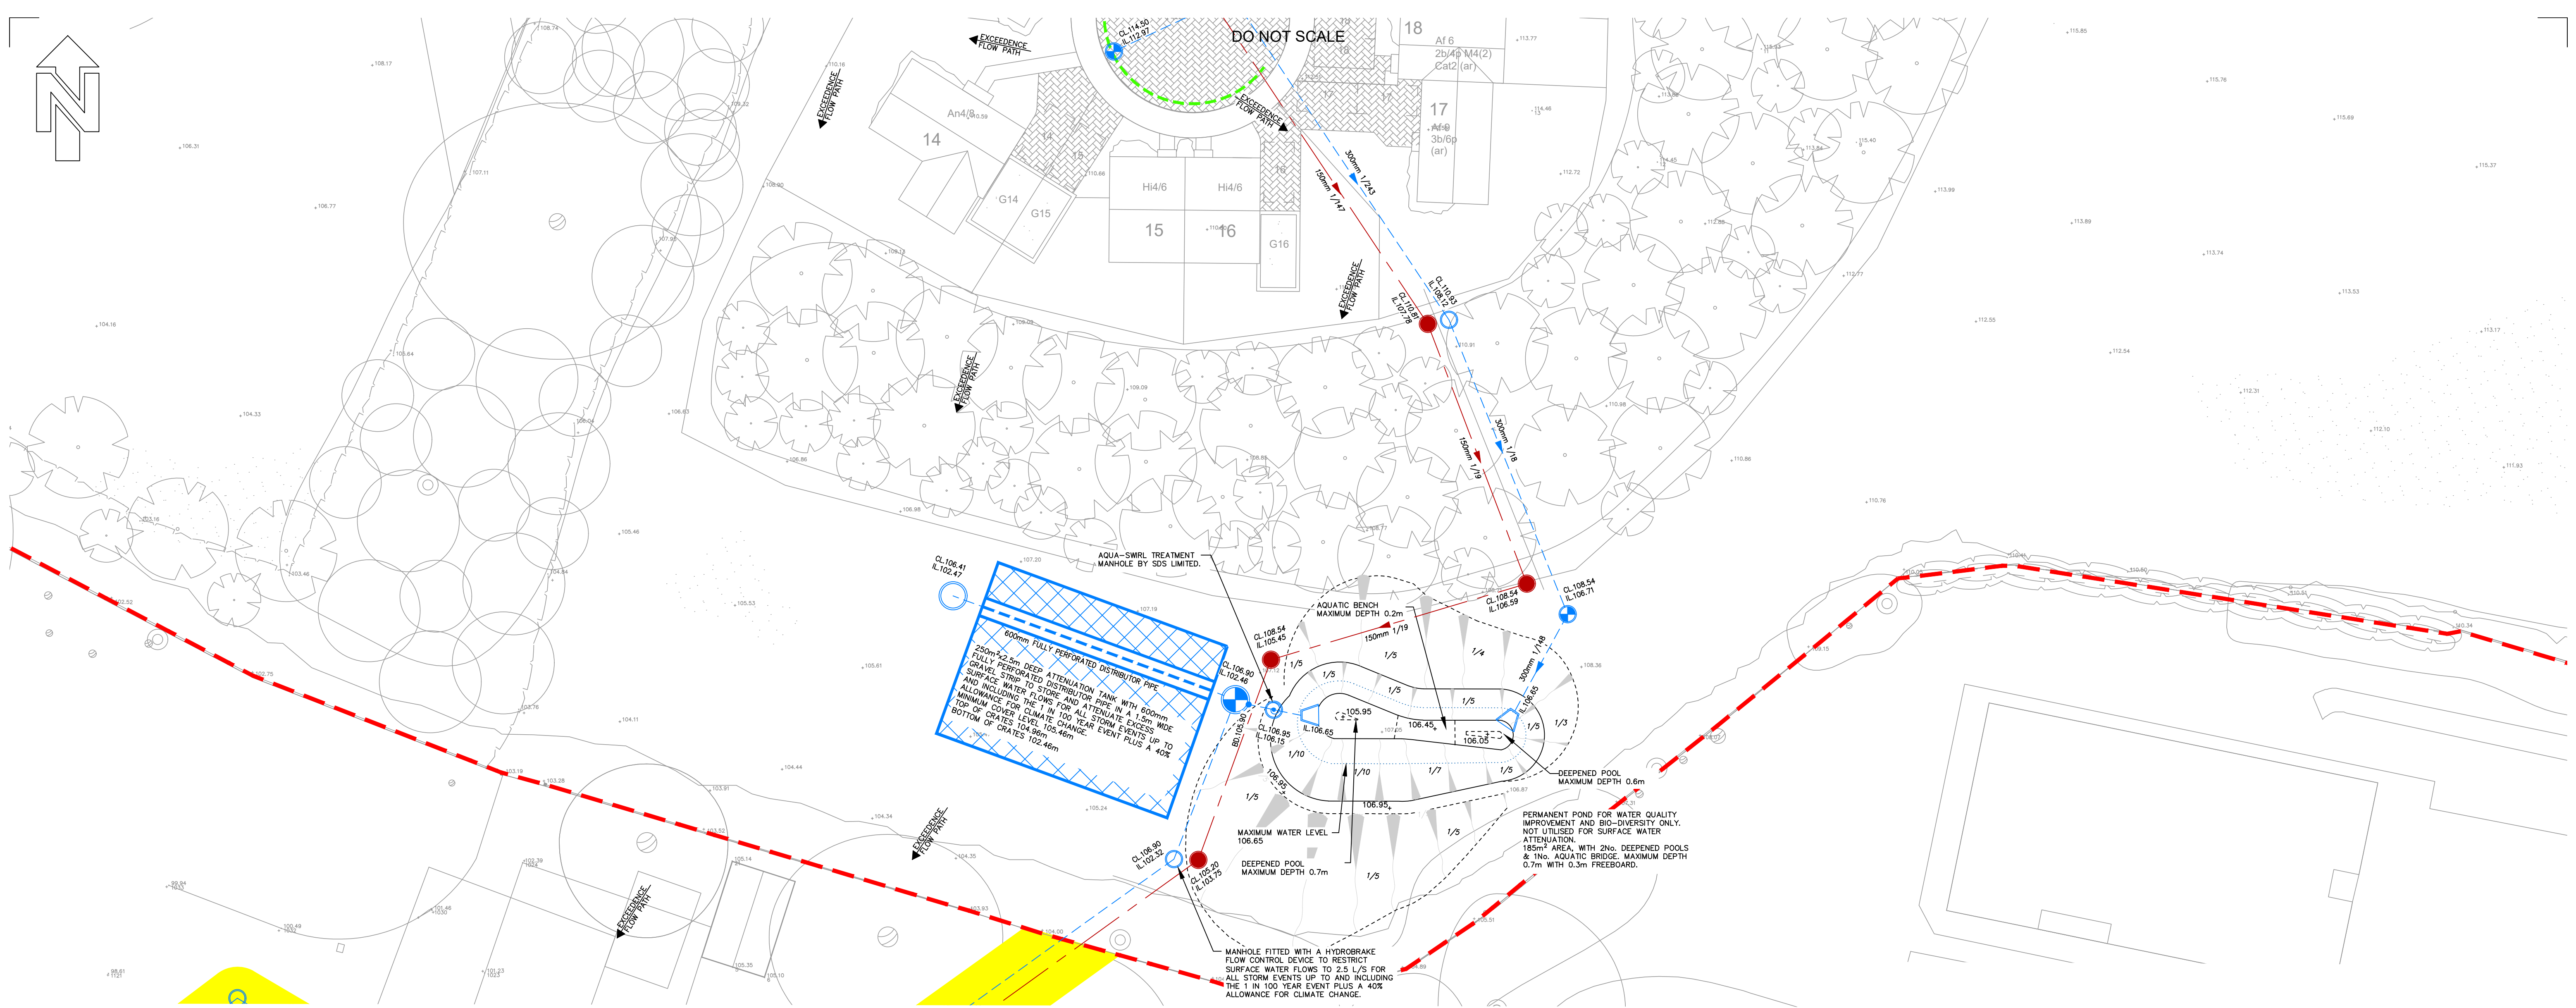

DRAINAGE LEGEND

- 150mm 1/100 Surface water sewer
- 150mm 1/100 Foul water sewer
- Perforated collector pipe
- Surface water catchpit manhole
- Surface water manhole
- Foul water manhole
- Denotes extent of permeable block paving
- Area of easement, min width of 2.5m either side of pipework
- Site boundary
- SDS Aqua-swirl

SURFACE WATER DESIGN NOTES 1

- It is understood that ground conditions are unsuitable for infiltration drainage techniques. Therefore, it is proposed to drain surface water runoff via a traditional network of underground pipework to an existing Severn Trent Water sewer located in Charlton Court Road.
- The sites greenfield runoff rate (QBAR) has been calculated as 2.5 litres / second using the IH124 method.
- Prior to discharging surface water flows to the surface water sewer, flows will be restricted to the sites greenfield runoff rate (QBAR) using a Hydrobrake flow control device, with excess surface water flows stored and attenuated within a below ground geocellular tank, for all return periods up to and including the 1 in 100 year design event plus a 40 allowance for climate change.
- Water quality improvements will be provided by the use of permeable block paving, a pond and a Hydrodynamic Vortex Separator 'Aquaswirl' by SDS Limited.

D	DRAWING UPDATED TO SUIT LATEST SITE LAYOUT.	JA	12.01.21
C	DRAWING UPDATED TO SUIT LATEST SITE LAYOUT. SURFACE WATER DISCHARGE RATE DECREASED TO SUIT REDUCED IMPERMEABLE AREA.	JA	15.04.20
B	DRAWING UPDATED TO SUIT LATEST SITE LAYOUT. SURFACE WATER DISCHARGE RATE DECREASED TO SUIT REDUCED IMPERMEABLE AREA.	LJK	22.05.19
A	DRAWING UPDATED TO SUIT LATEST SITE LAYOUT.	EL	22.10.18
MK	REVISION	BY	DATE

DRAWING STATUS
PLANNING

DRAWING TITLE
DRAINAGE LAYOUT SHEET 2 OF 2

PROJECT	Project NumberC21505
---------	----------------------

OAKHURST RISE
CHARLTON KINGS
CHELTENHAM

Unit B10
Elmbridge Court Business Park
Gloucester GL3 1JZ
T.01452 308 727

London, Henley-on Thames and Gloucester

Drawn EL	Chkd AGC	Scales 1:250 @ A1	Date OCT 2018
Purpose of Issue PLANNING			
Drawing Number C21505 - SK02			Revision D